


SITE PLAN
(Not To Scale)

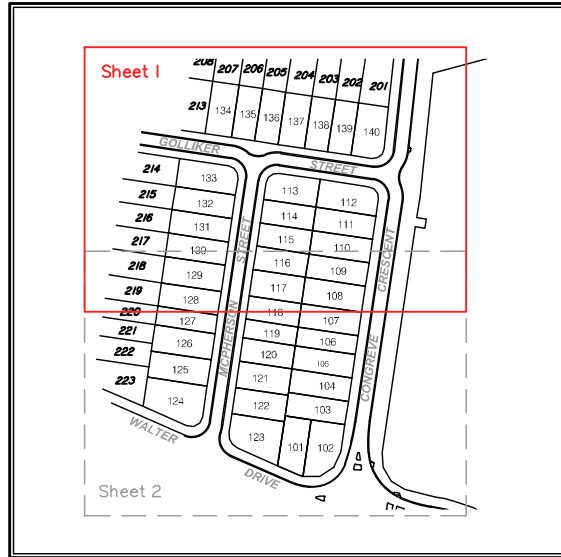

NOTE:
Design services shown hereon have been plotted from data supplied by Bligh Tanner on 21/07/2016, (Operational Works Reference: OPW002005.0B).

LEGEND

- S SEWER LINE
- W WATER LINE
- SW STORMWATER LINE
- E ELECTRICITY LINE
- NBN NATIONAL BROADBAND NETWORK (NBN) LINE
- S EXISTING SEWER
- W EXISTING WATER
- SW EXISTING STORMWATER
- SEWER MANHOLES
- FIRE HYDRANT (FH)
- WATER VALVE
- WATER SERVICE POINT
- GULLY PIT / STORMWATER MANHOLE
- ELECTRICAL PITS
- ⊙ LIGHT POLE
- NBN PIT



JOINS SHEET 2

ISSUE	DATE	AUTHOR	COMMENTS	ISSUE	DATE	AUTHOR	COMMENTS
A	28/07/2016	SSJ	INITIAL ISSUE				
B	14/09/2016	MIS	REPLACED SEWER, STORMWATER AND WATER SERVICES AS PER 676501B2				



Brisbane Office
Level 3, Kings Row 4,
40 McDougall Street,
Milton QLD 4064

PO Box 3916
South Brisbane BC QLD 4101
t (07) 3842 1000
f (07) 3842 1001
e info@landpartners.com.au
www.landpartners.com.au

CLIENT
ORCHARD PROPERTY GROUP

PROJECT
**SERVICE LOCATION PLAN
THE RISE
THORNLANDS STAGE 1**


ENGINEERING CONSULTANT
BLIGH TANNER

LOCAL GOVERNMENT
REDLAND CITY COUNCIL

SCALE
6 0 15 35m
SCALE 1:600 @ A3

SHEET		Sheet 1 of 2	
DATUM	AHD	LEVEL ORIGIN	PM16638 RL55.339
CONTOUR INTERVAL	0.5m	COMPUTER FILE	676501B3
DRAWN	MIS	DATE	15/09/2016
CHECKED	MEA	DATE	15/09/2016
APPROVED	SRS	DATE	15/09/2016
PLAN NUMBER	BRSS6755.001-042	REVISION	B


SITE PLAN
(Not To Scale)

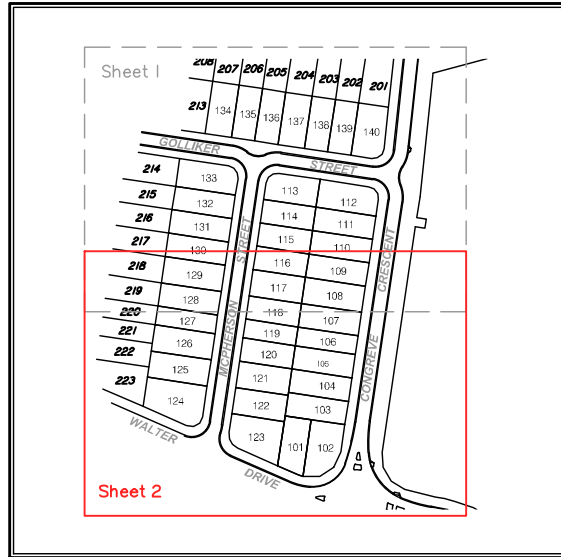

NOTE:
Design services shown hereon have been plotted from data supplied by Bligh Tanner on 21/07/2016, (Operational Works Reference: OPW002005.0B).

LEGEND

- S SEWER LINE
- W WATER LINE
- SW STORMWATER LINE
- E ELECTRICITY LINE
- NBN NATIONAL BROADBAND NETWORK (NBN) LINE
- S EXISTING SEWER
- W EXISTING WATER
- SW EXISTING STORMWATER
- SEWER MANHOLES
- FIRE HYDRANT (FH)
- WATER VALVE
- WATER SERVICE POINT
- GULLY PIT / STORMWATER MANHOLE
- ELECTRICAL PITS
- ☼ LIGHT POLE
- NBN PIT

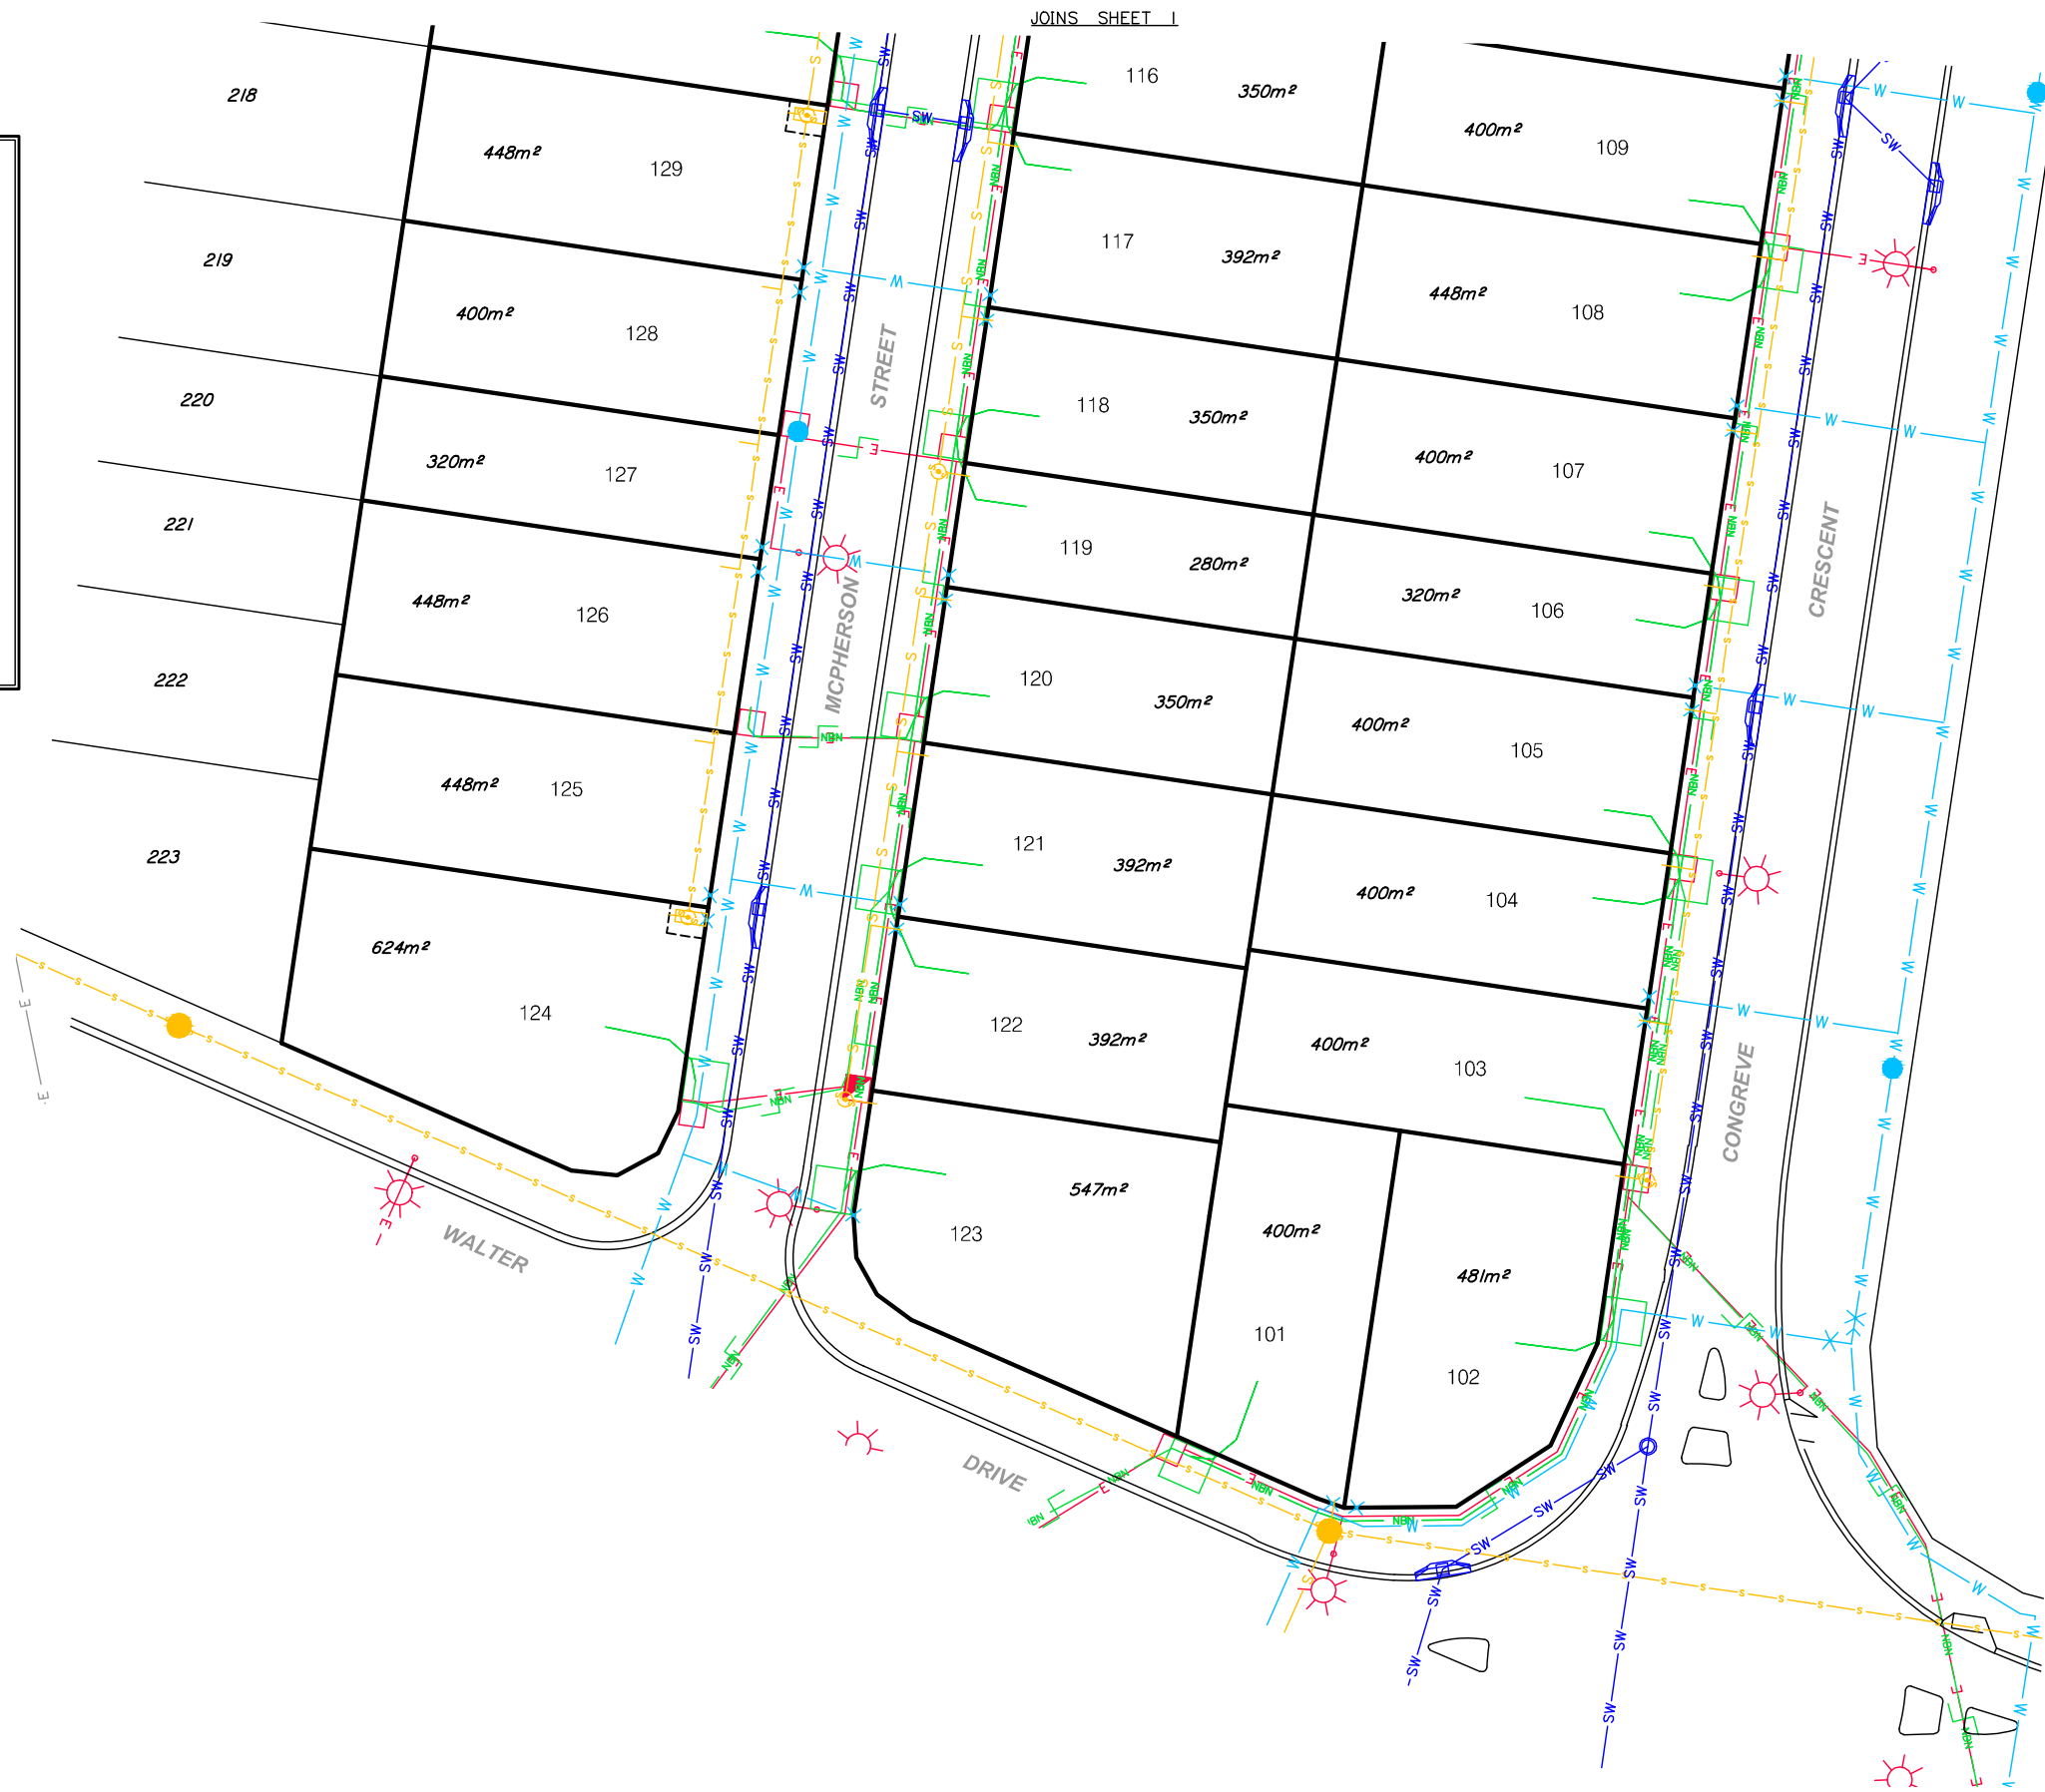

ISSUE	DATE	AUTHOR	COMMENTS	ISSUE	DATE	AUTHOR	COMMENTS
A	28/07/2016	SSJ	INITIAL ISSUE				
B	14/09/2016	MIS	REPLACED SEWER, STORMWATER AND WATER SERVICES AS PER 676501B2				



Brisbane Office
Level 3, Kings Row 4,
40 McDougall Street,
Milton QLD 4064

PO Box 3916
South Brisbane BC QLD 4101
t (07) 3842 1000
f (07) 3842 1001
e info@landpartners.com.au
www.landpartners.com.au

CLIENT
ORCHARD PROPERTY GROUP

PROJECT
**SERVICE LOCATION PLAN
THE RISE
THORNLANDS STAGE 1**

ENGINEERING CONSULTANT
BLIGH TANNER

LOCAL GOVERNMENT
REDLAND CITY COUNCIL

SCALE
6 0 15 35m
SCALE 1:600 @ A3

SHEET Sheet 2 of 2	
DATUM	AHD
LEVEL ORIGIN	PM166638 RL55.339
CONTOUR INTERVAL	0.5m
COMPUTER FILE	675501B3
DRAWN	MIS DATE 15/09/2016
CHECKED	MEA DATE 15/09/2016
APPROVED	SRS DATE 15/09/2016
PLAN NUMBER	BRSS6755.001-042
REVISION	B